

**SITE PLAN**  
SCALE: NONE

**LEGEND**

- DENOTES IRON MONUMENT FOUND
- DENOTES IRON MONUMENT SET
- ⊙ DENOTES EVERGREEN TREE
- ⊙ DENOTES EVERGREEN TREE
- ⊙ DENOTES DECIDUOUS TREE
- ⊙ DENOTES LIGHT POLE
- ⊙ DENOTES GUY WIRE
- ⊙ DENOTES POWER POLE
- ⊙ DENOTES CATCH BASIN
- ⊙ DENOTES WATER VALVE
- ⊙ DENOTES FIRE HYD
- ⊙ DENOTES DRAINAGE MANHOLE
- ⊙ DENOTES SANITARY MANHOLE
- ⊙ DENOTES TREE & BRUSH LINE
- DENOTES SANITARY SEWER LINE
- DENOTES WATER MAIN LINE
- DENOTES STORM SEWER LINE
- DENOTES FENCE
- DENOTES FIBER OPTIC LINE
- DENOTES OVERHEAD ELECTRIC LINE
- DENOTES GAS LINE (BURIED)
- DENOTES TELEPHONE LINE (BURIED)
- DENOTES ELECTRIC LINE (BURIED)

DESIGNED	DJM
DRAWN	LMM
CHECKED	DJM
PROJECT	14-062
REVISIONS	

I hereby certify that this plan, specification or report was prepared by me or under my direct supervision and that I am a duly licensed architect under the laws of the state of Minnesota. (architectural only)

DAVID J. MEDIN  
License No. 2848  
Date Dec 08, 2016

**NORTHFIELD FIRE STATION STUDY**  
MINNESOTA,  
NORTHFIELD,

203 N.W. First Ave.  
Faribault, MN 55021  
507/334-2252



SITE PLAN

A1.0

I hereby certify that this specification or report was prepared by me or under my direct supervision and that I am a duly licensed architect under the laws of the state of Minnesota.  
(architectural only)

NORTHFIELD FIRE STATION STUDY

---


NORTHFIELD, MINNESOTA

203 n.w. First Ave  
Faribault, MN 55009  
507/334-2252




LOWER  
FLOOR PL

A3.

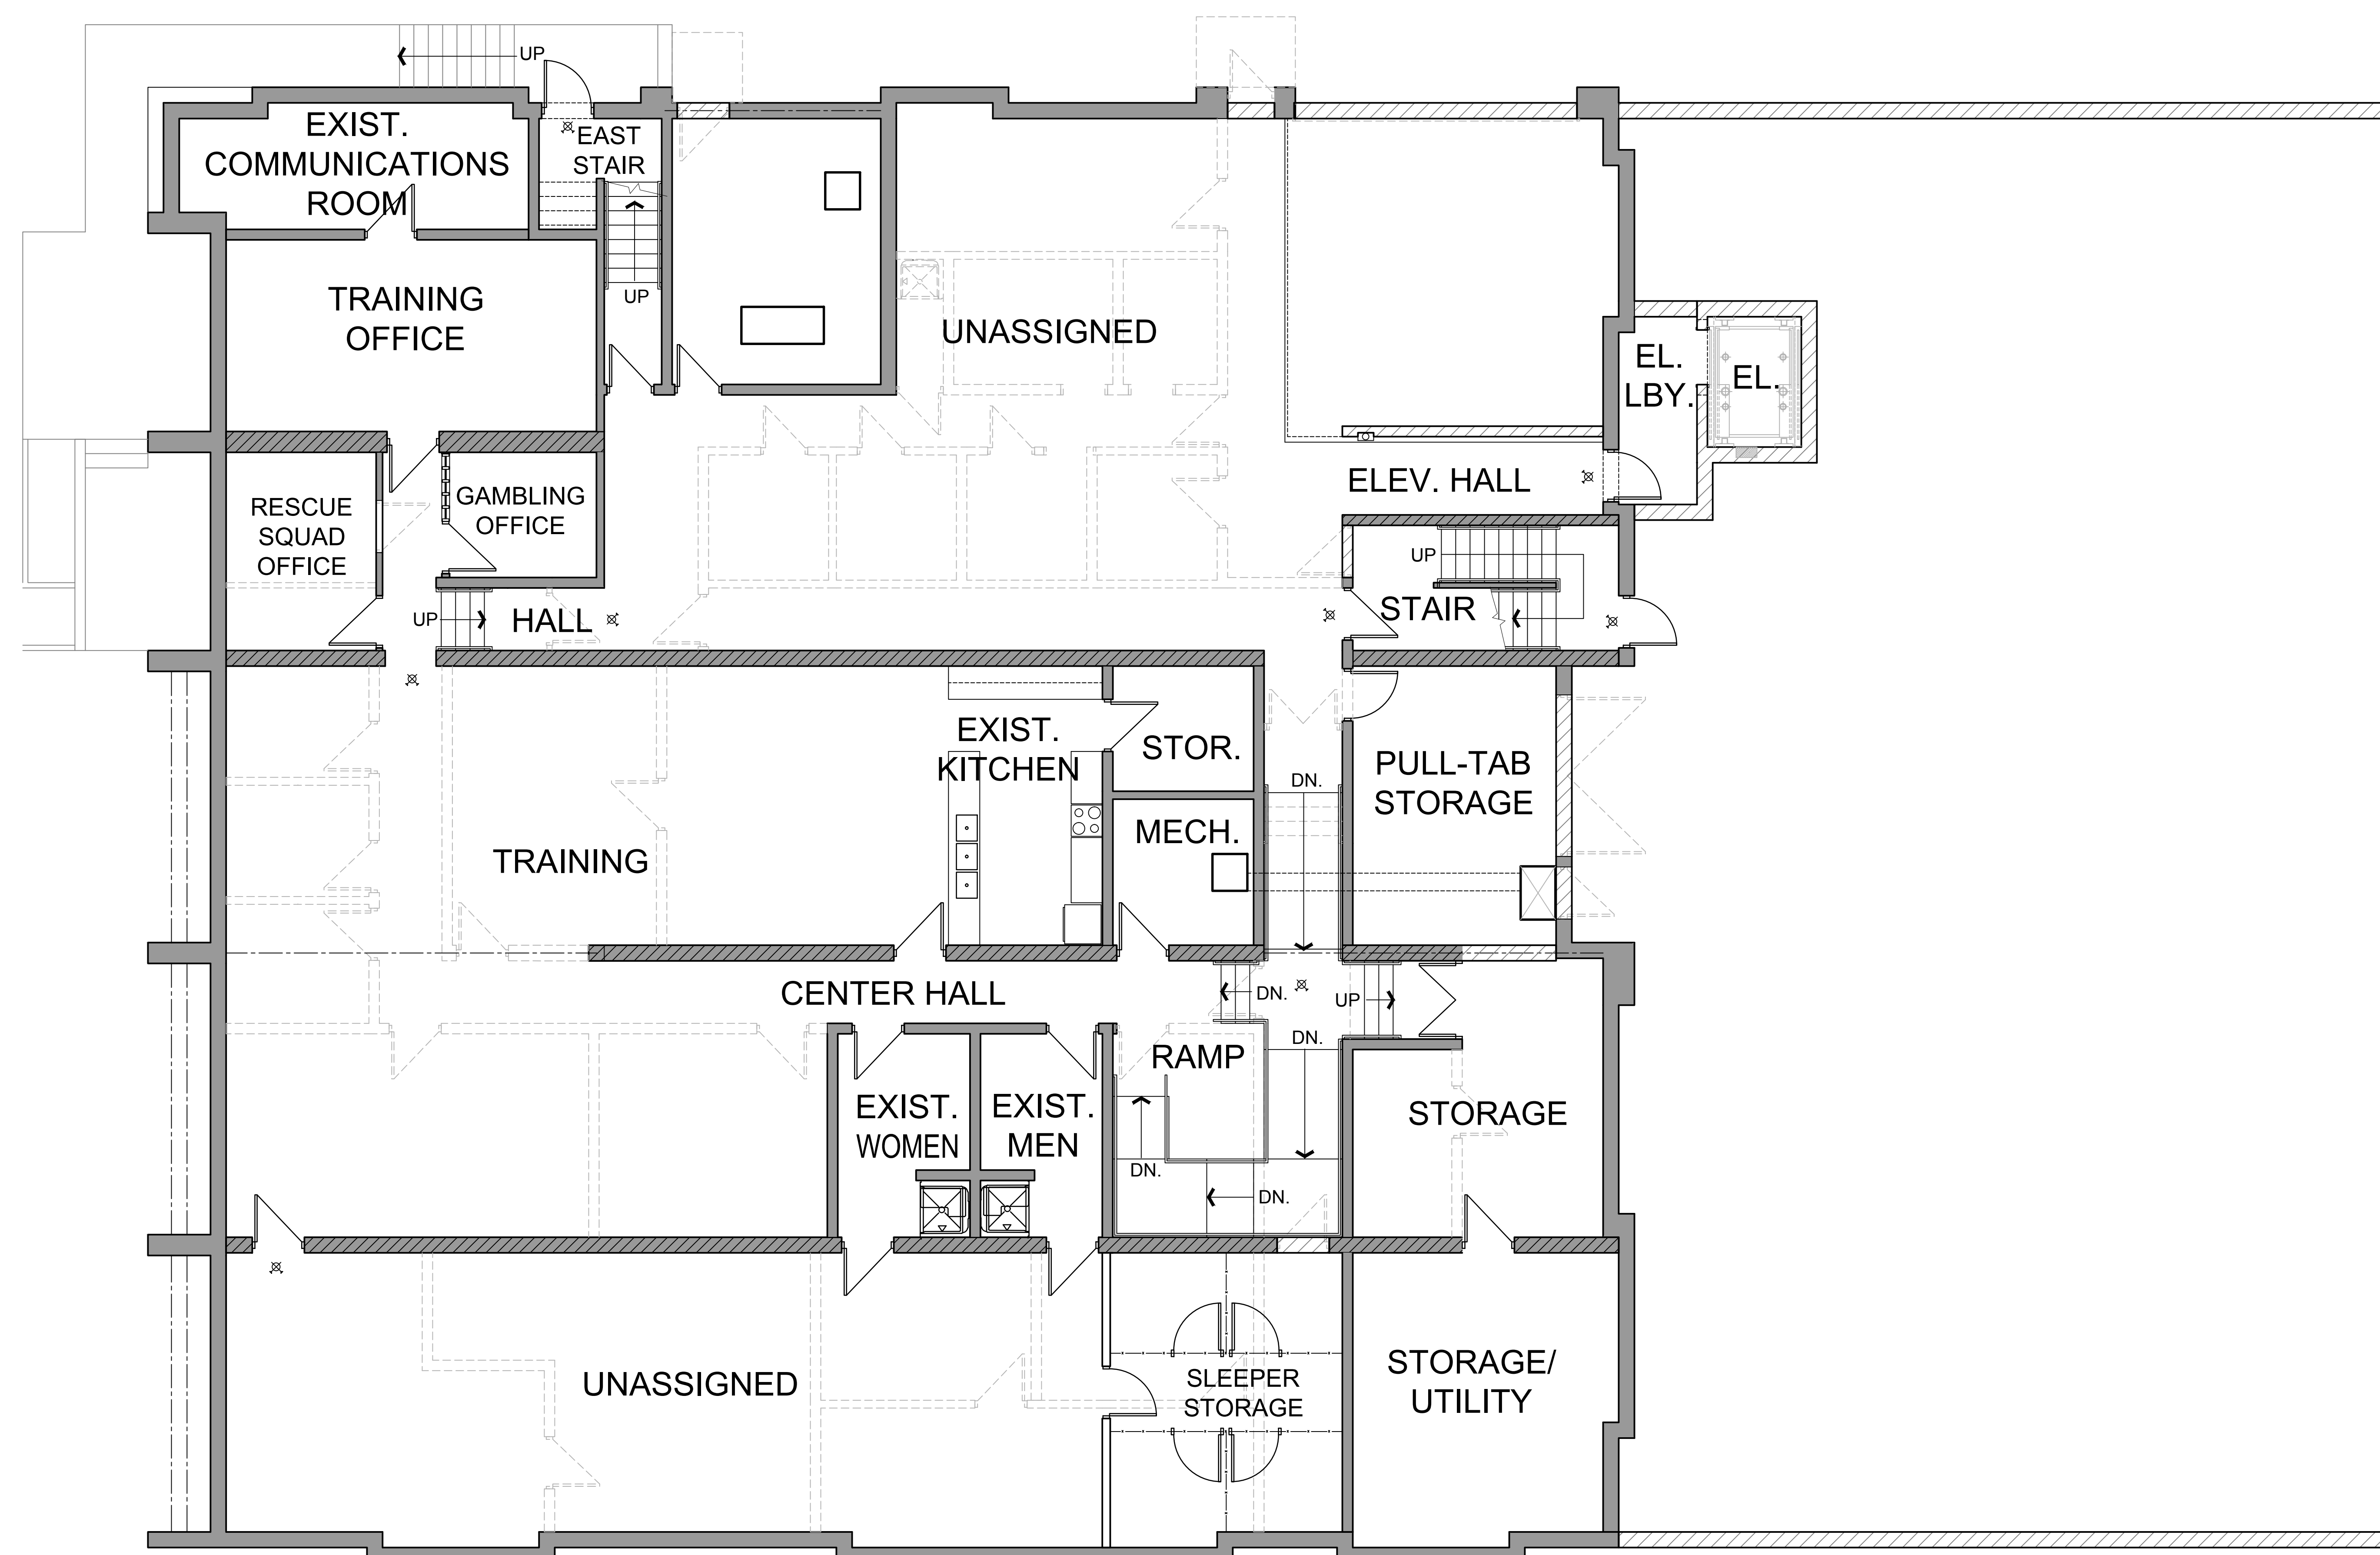

  **LOWER FLOOR PLAN**  
SCALE: 3/16"=1'-0"  
NORTH



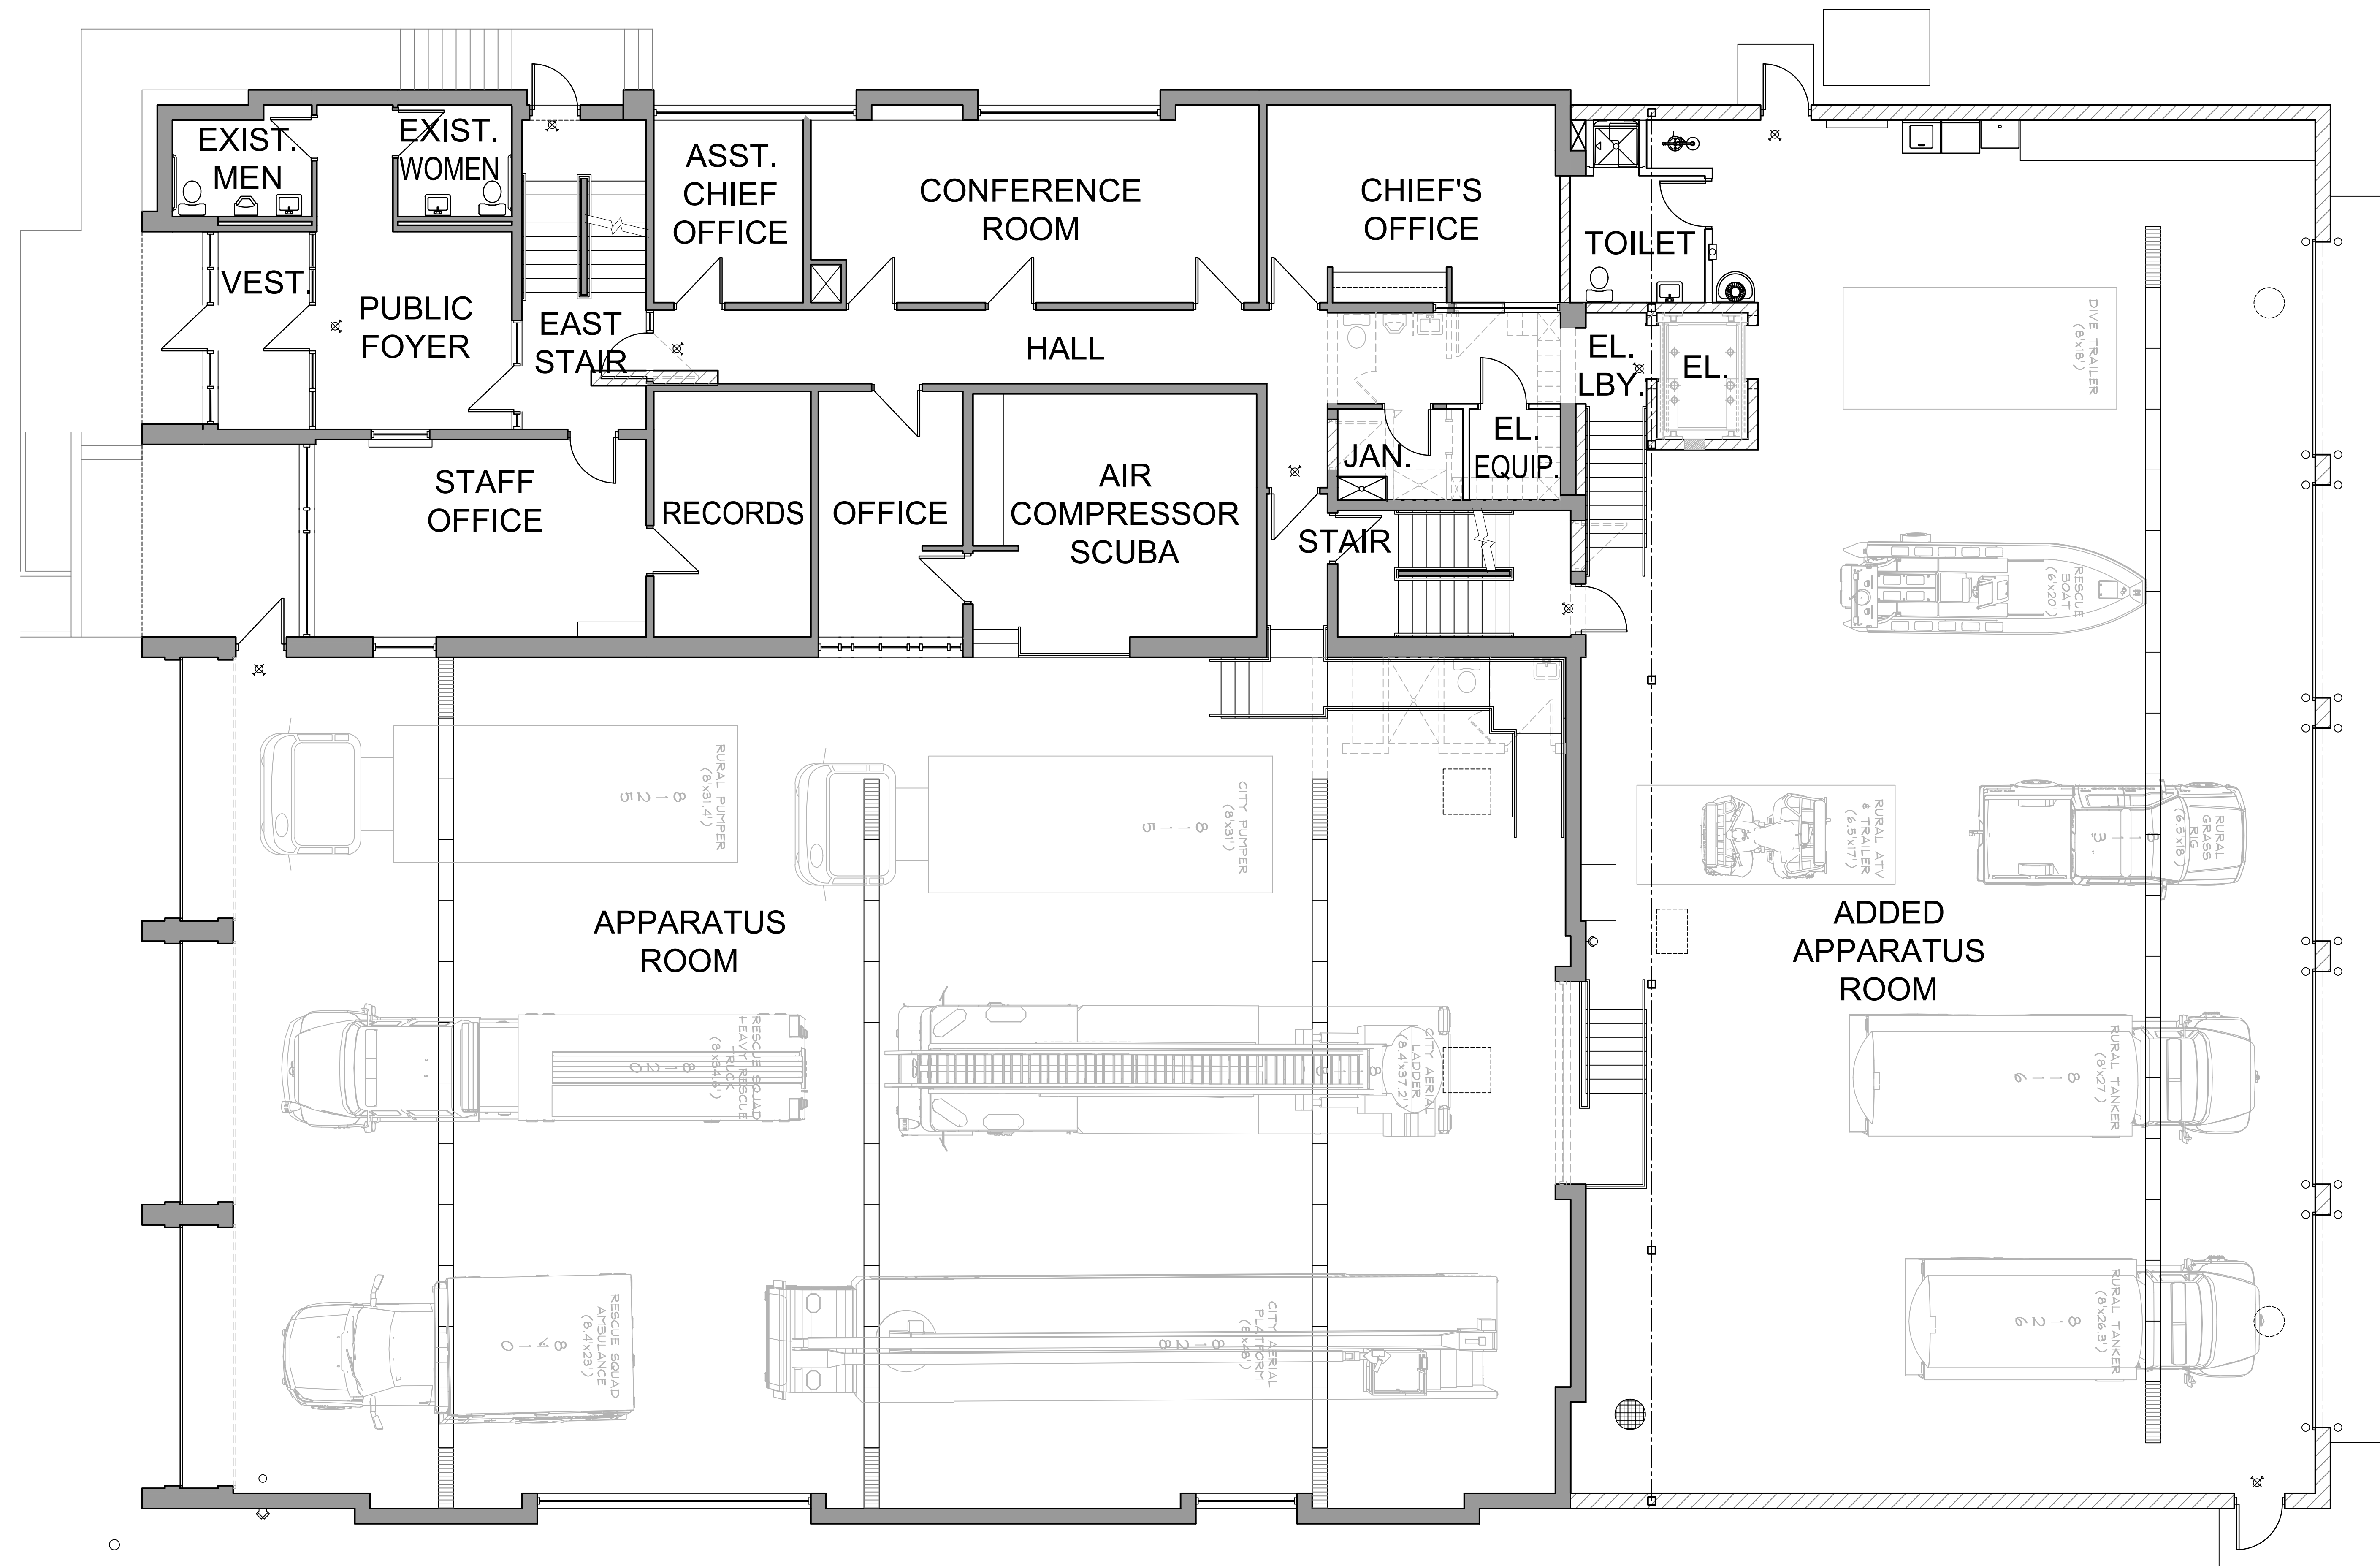

**MAIN FLOOR PLAN**  
 SCALE: 3/16"=1'-0"  
 NORTH

DESIGNED	DJM
DRAWN	LMM
CHECKED	DJM
PROJECT	14-062
REVISIONS	

I hereby certify that this plan, specification or report was prepared by me or under my direct supervision and that I am a duly licensed architect under the laws of the state of Minnesota. (architectural only)


DAVID J. MEDIN  
 License No. 2898  
 Date Dec 08, 2016


# NORTHFIELD FIRE STATION STUDY MINNESOTA NORTHFIELD,

203 N.W. First Ave.  
 Faribault, MN 55021  
 507/334-2252



MAIN  
 FLOOR PLAN  
**A3.0**

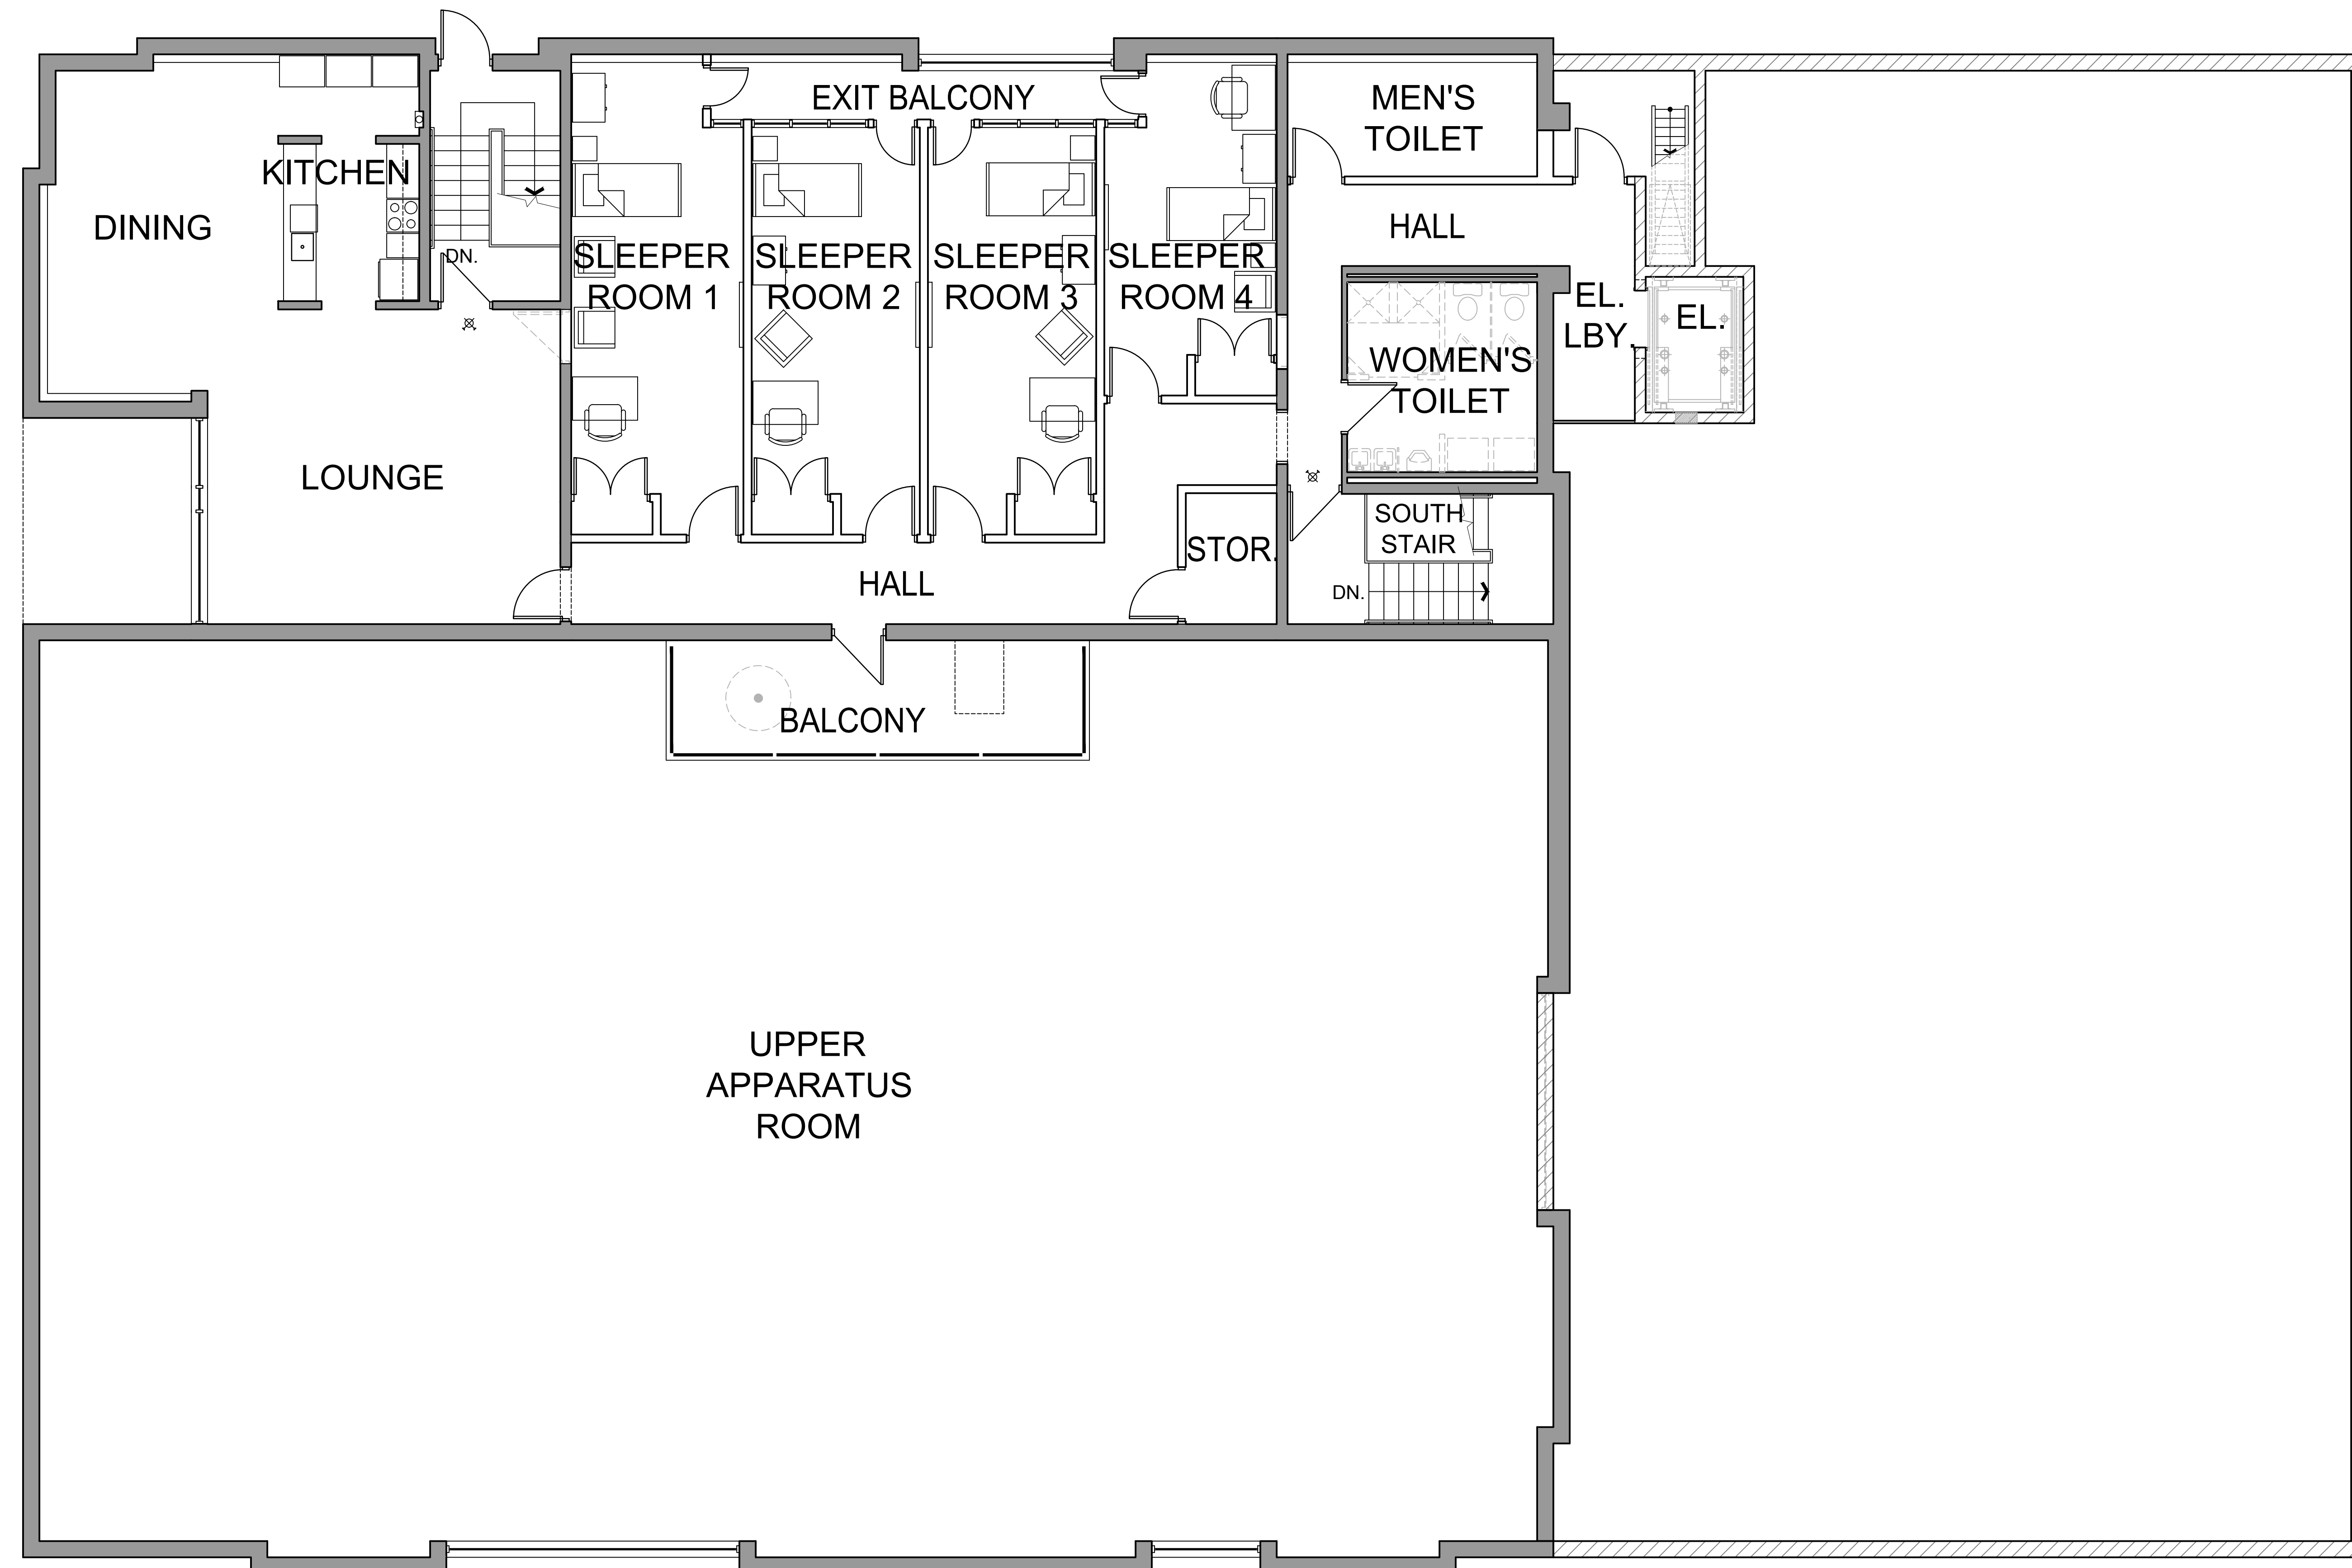

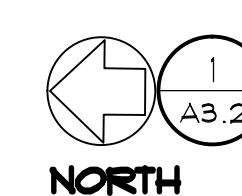 **UPPER FLOOR PLAN**  
SCALE: 3/16"=1'-0"

DESIGNED	DJM
DRAWN	LMM
CHECKED	DJM
PROJECT	14-062
REVISIONS	

I hereby certify that this plan, specification or report was prepared by me or under my direct supervision and that I am a duly licensed architect under the laws of the state of Minnesota. (architectural only)

DAVID J. MEDIN  
License No. 0898  
Date Dec 08, 2016

**NORTHFIELD FIRE STATION STUDY**  
NORTHFIELD, MINNESOTA

203 N.W. First Ave.  
Faribault, MN 55021  
507/334-2252

**DJ MEDIN**  
architects, inc.

UPPER  
FLOOR PLAN

**A3.2**